

AECOM

111 N.E. Jefferson Ave.
 Peoria, Illinois 61602
 309-676-8464
 www.aecom.com
 Copyright © 2009 by AECOM
 IL Design Firm Reg. Nos.
 AECOM USA, Inc.
 No. 184-003706
 AECOM Technical Services
 No. 184-000178

MORTON YOUTH
 BASEBALL ASSOCIATION
 MORTON, ILLINOIS

OVERALL CONTEXTUAL SITE PLAN

X:\PROJECTS\60099502\DWG\60099502_C1_OVERALL.DWG


Drawn: NHP 08/20/09

Checked:

Approved:

PROJECT NUMBER 60099502

FIGURE NUMBER C1

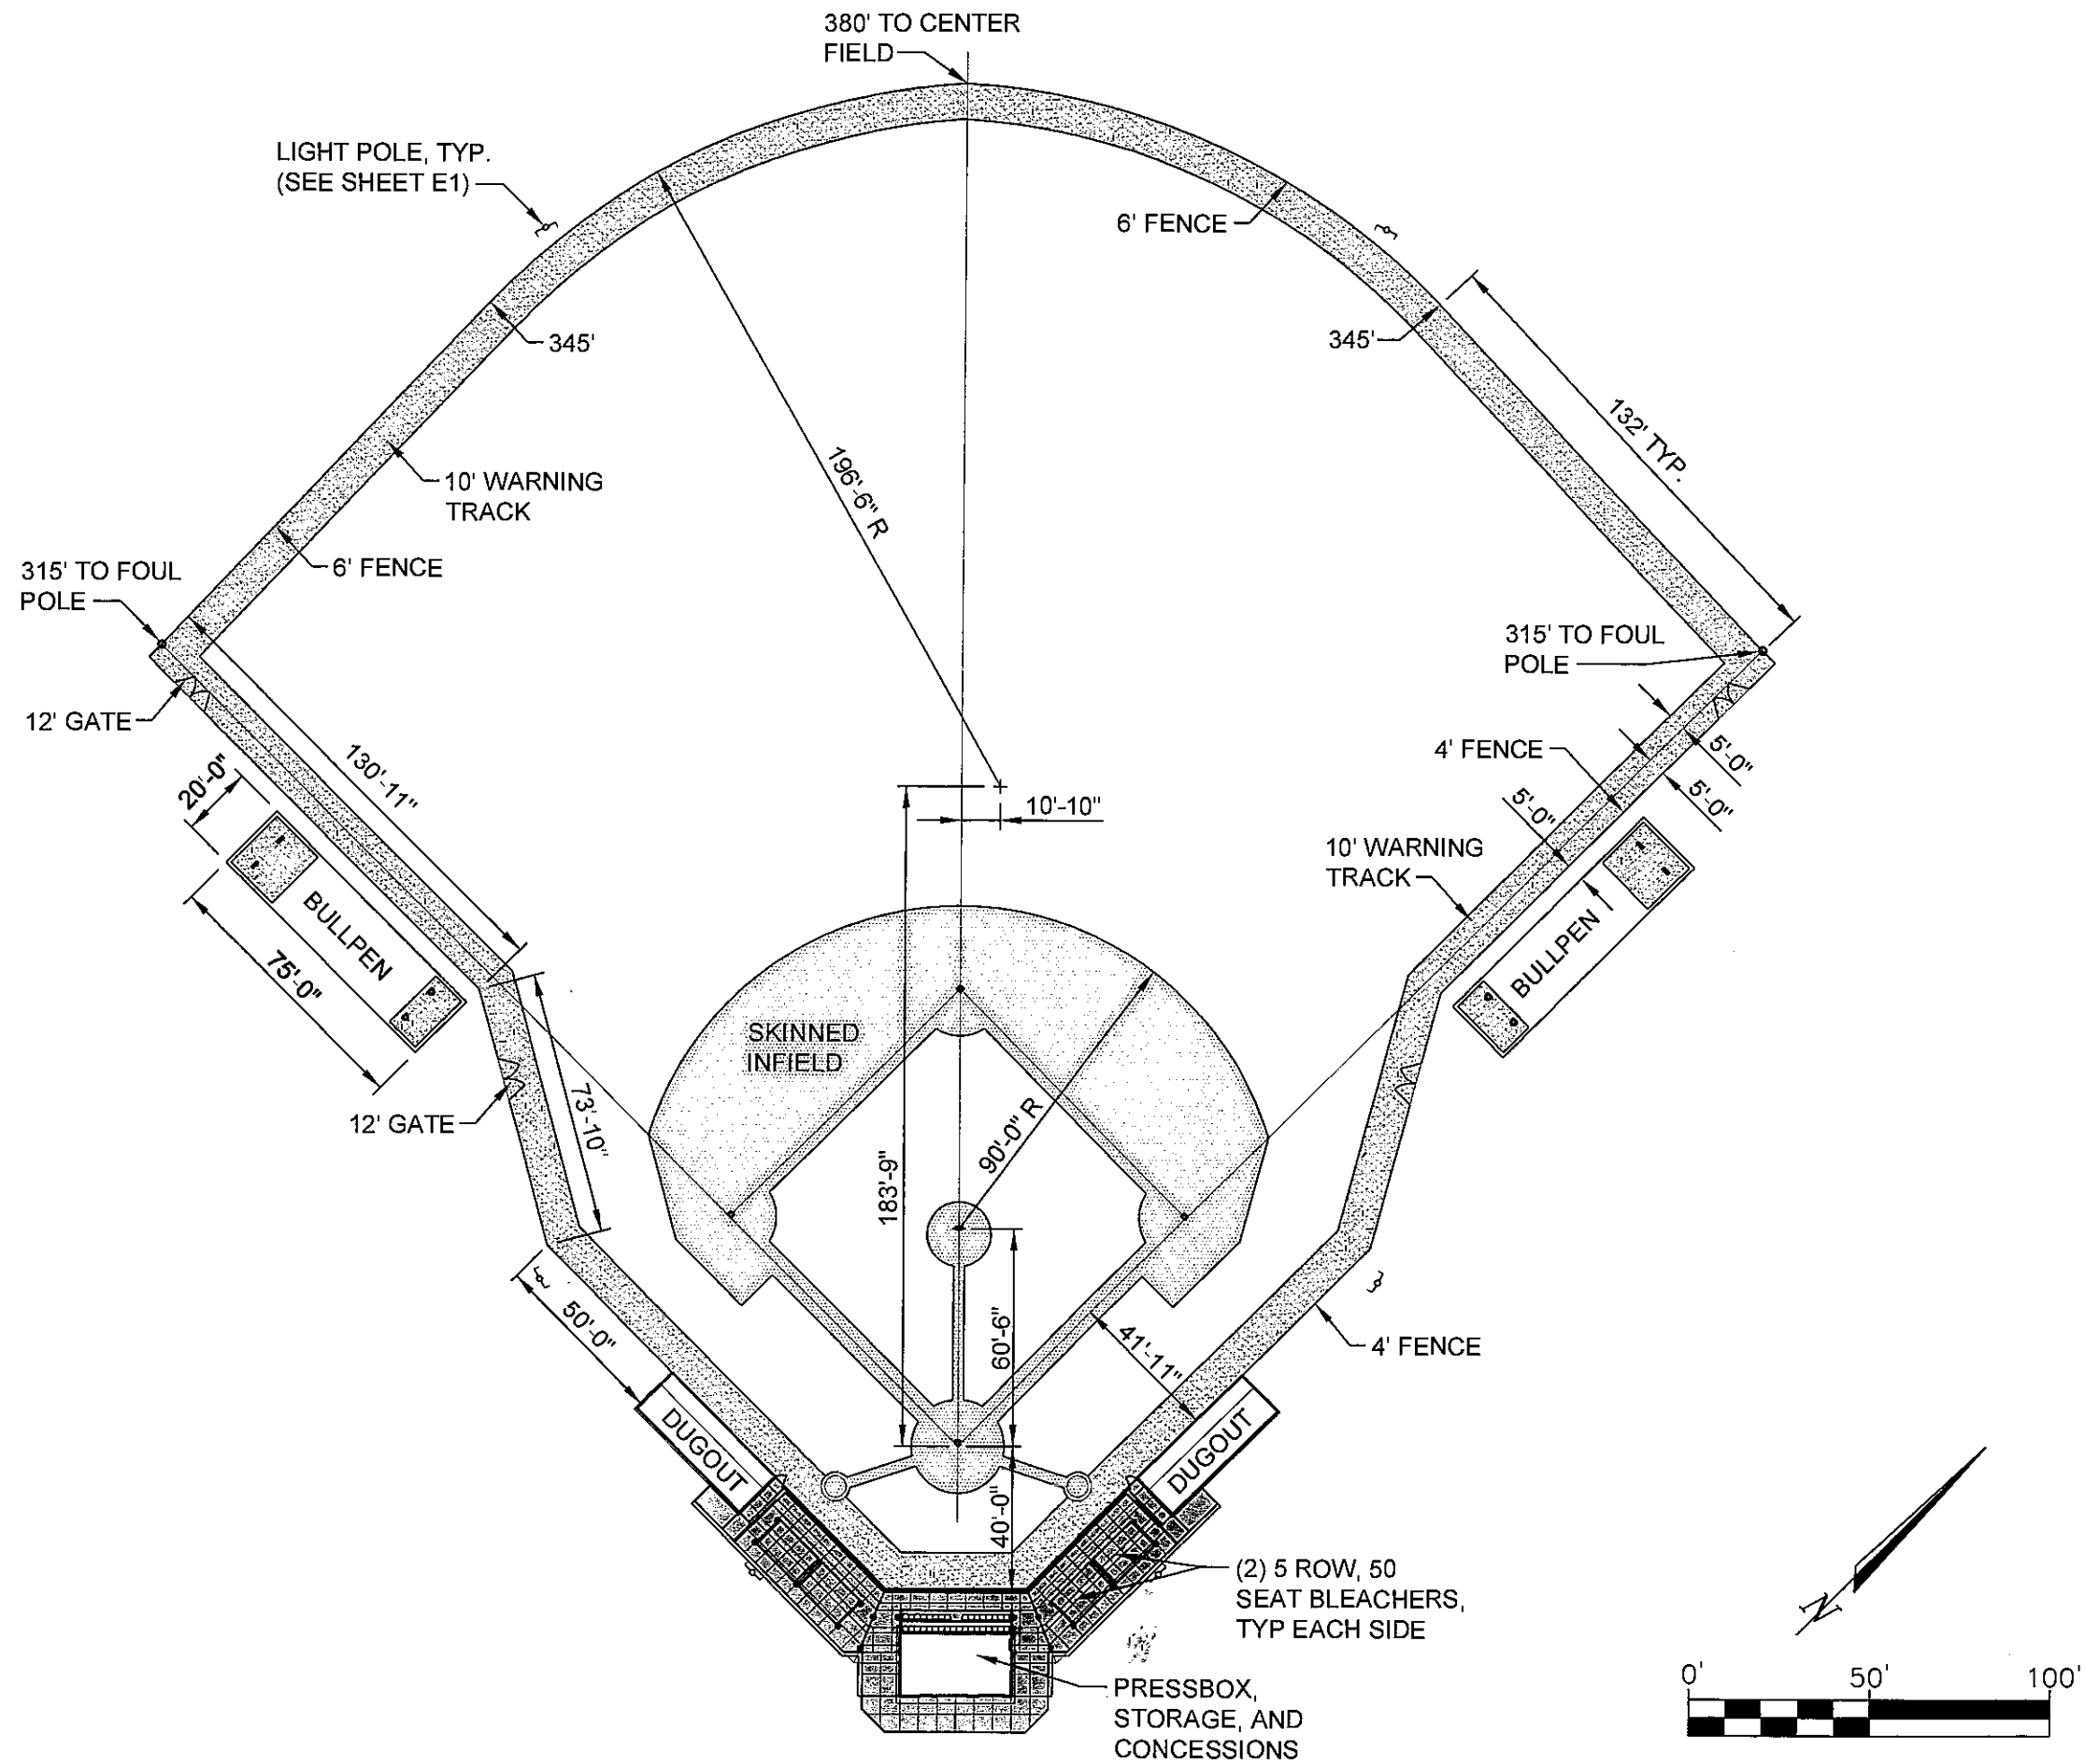

AECOM

111 N.E. Jefferson Ave.
 Peoria, Illinois 61602
 309-676-8464
 www.aecom.com
 Copyright © 2009 by AECOM
 IL Design Firm Reg. Nos.
 AECOM USA, Inc.
 No. 184-003706
 AECOM Technical Services
 No. 184-000178

MORTON YOUTH
 BASEBALL ASSOCIATION
 MORTON, ILLINOIS

OVERALL SITE PLAN

X:\PROJECTS\60099502\DWG\60099502_C2_OVERALL.DWG


Drawn: NHP 08/20/09

Checked:

Approved:

PROJECT NUMBER 60099502

FIGURE NUMBER C2

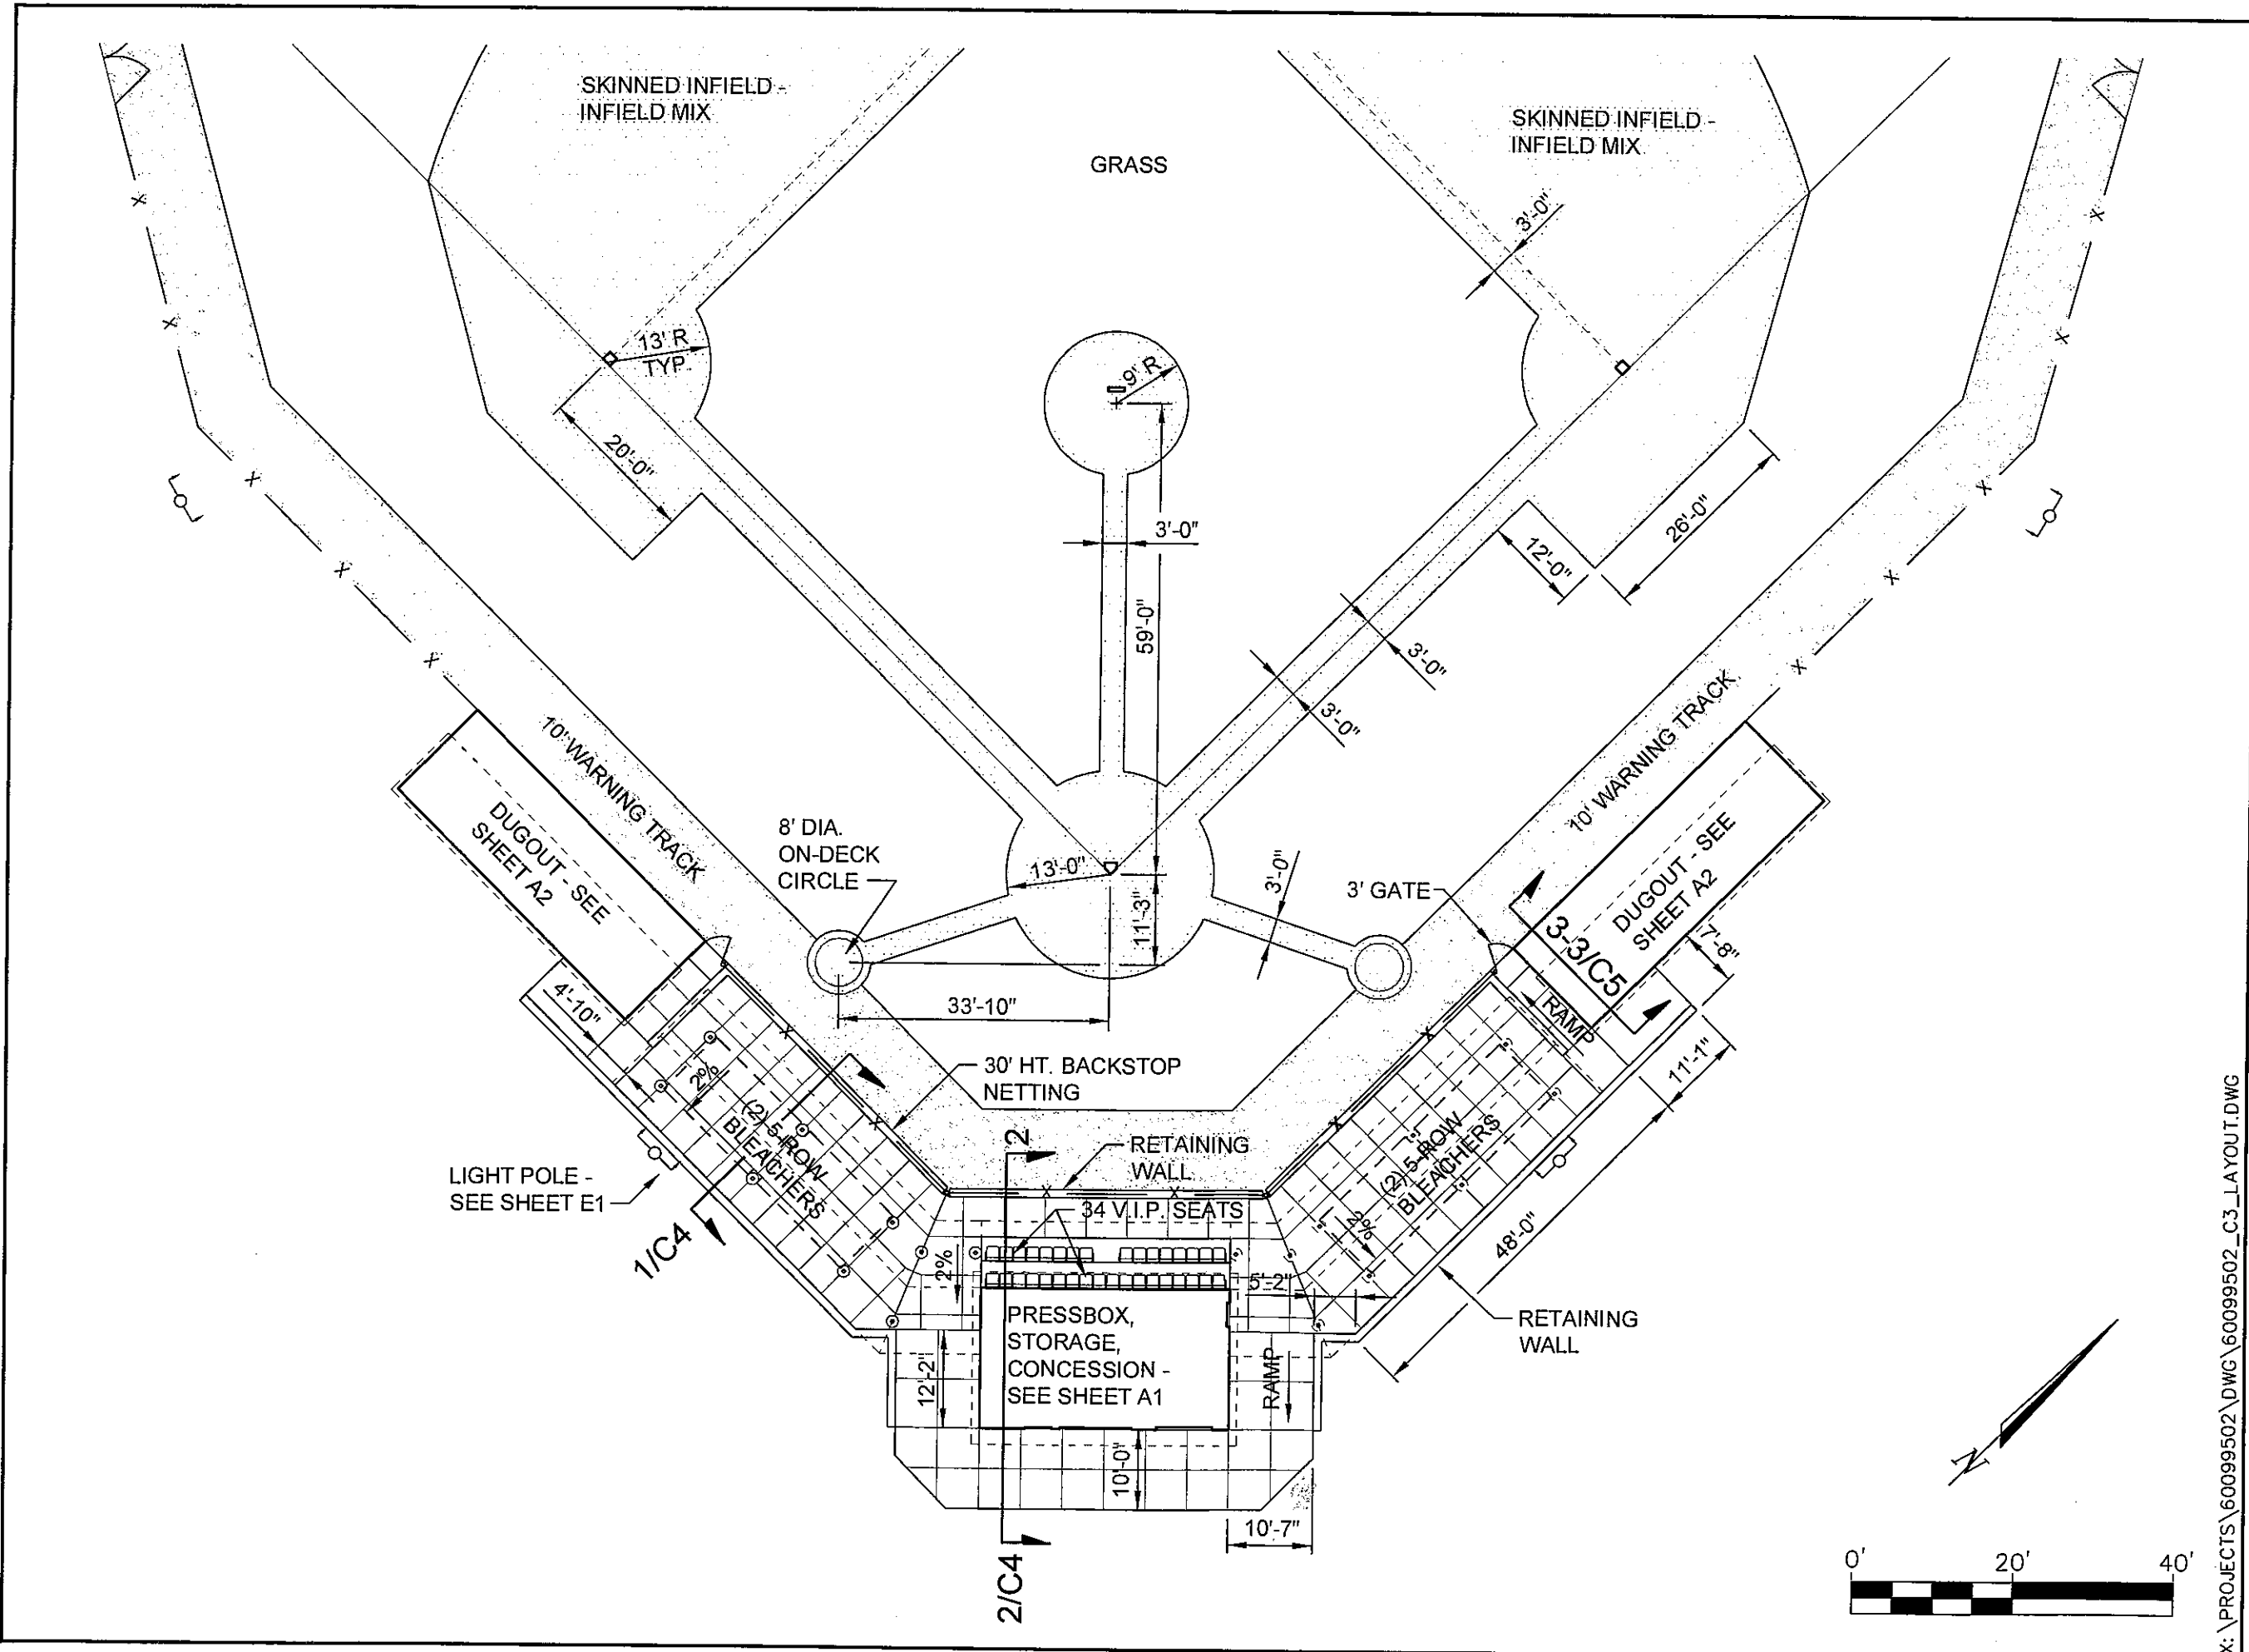

AECOM


111 N.E. Jefferson Ave.
 Peoria, Illinois 61602
 309-676-8464
 www.aecom.com
 Copyright © 2009 by AECOM
 IL Design Firm Reg. Nos.
 AECOM USA, Inc.
 No. 184-003706
 AECOM Technical Services
 No. 184-000178

MORTON YOUTH
 BASEBALL ASSOCIATION
 MORTON, ILLINOIS

ENLARGED SITE PLAN


X:\PROJECTS\60099502\DWG\60099502_C3_LAYOUT.DWG

Drawn:	NHP 08/20/09
Checked:	
Approved:	
PROJECT NUMBER	60099502
FIGURE NUMBER	C3

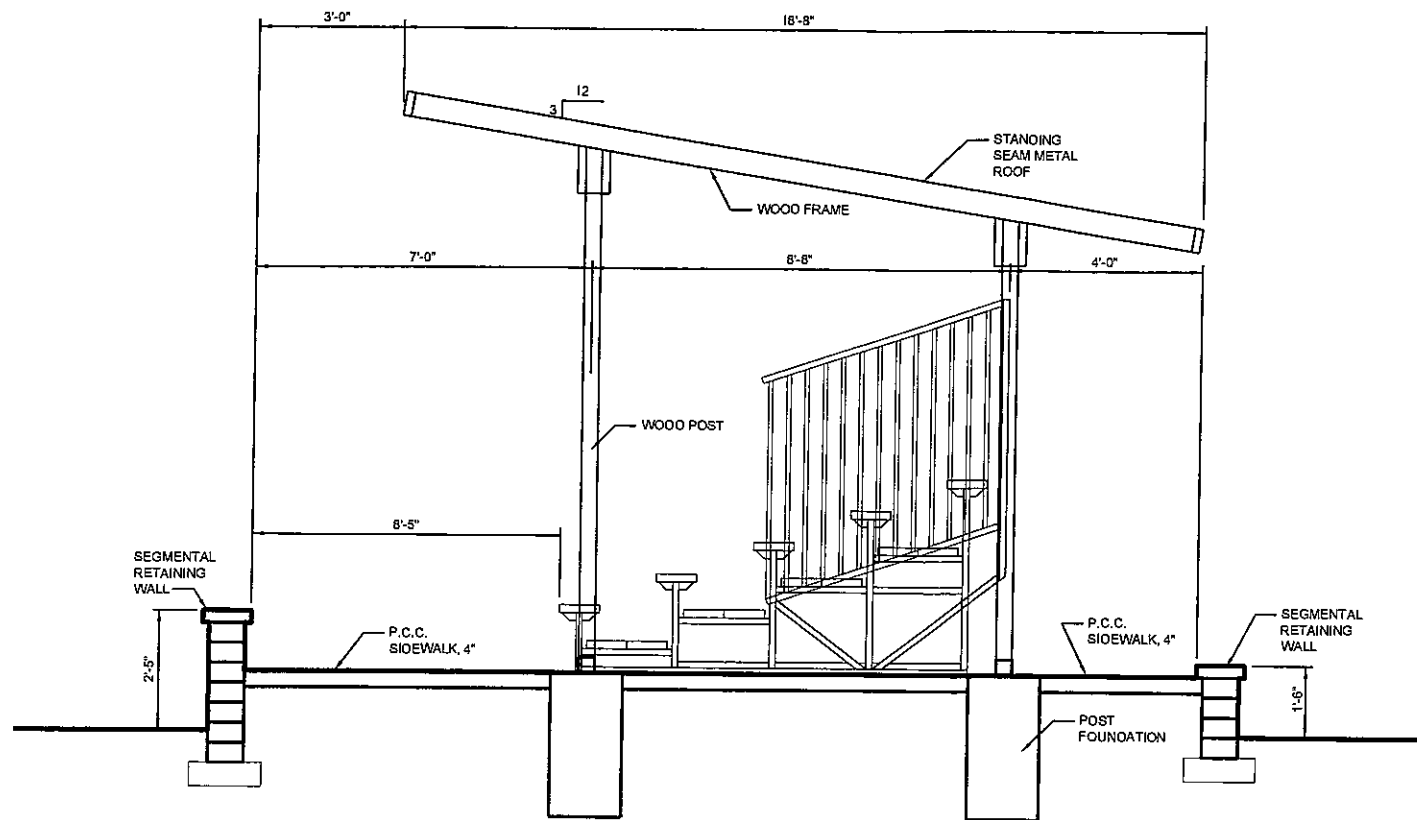

BLEACHER SECTION 1-1

SCALE: 1/4"=1'-0"

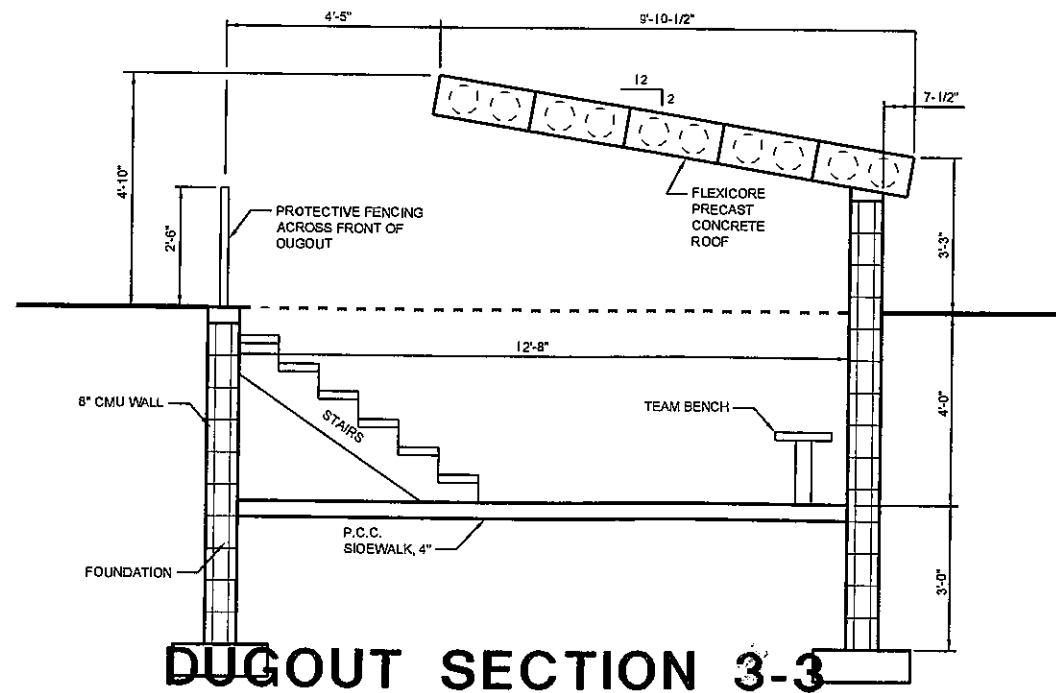

DUGOUT SECTION 3-3

SCALE: 1/4"=1'-0"

AECOM

111 N.E. Jefferson Ave.
Peoria, Illinois 61602
309-676-8464
www.aecom.com
Copyright © 2009 by AECOM
IL Design Firm Reg. Nos.
AECOM USA, Inc.
No. 184-003706
AECOM Technical Services
No. 184-000178

MORTON YOUTH
BASEBALL ASSOCIATION
MORTON, ILLINOIS

BLEACHER AND DUGOUT SECTION

X:\PROJECTS\60099502\DWG\60099502_C4_SECTION.DWG

Drawn : NHP 08/20/09


Checked:

Approved:

PROJECT NUMBER 60099502

FIGURE NUMBER C4

MORTON YOUTH
 BASEBALL ASSOCIATION
 MORTON, ILLINOIS

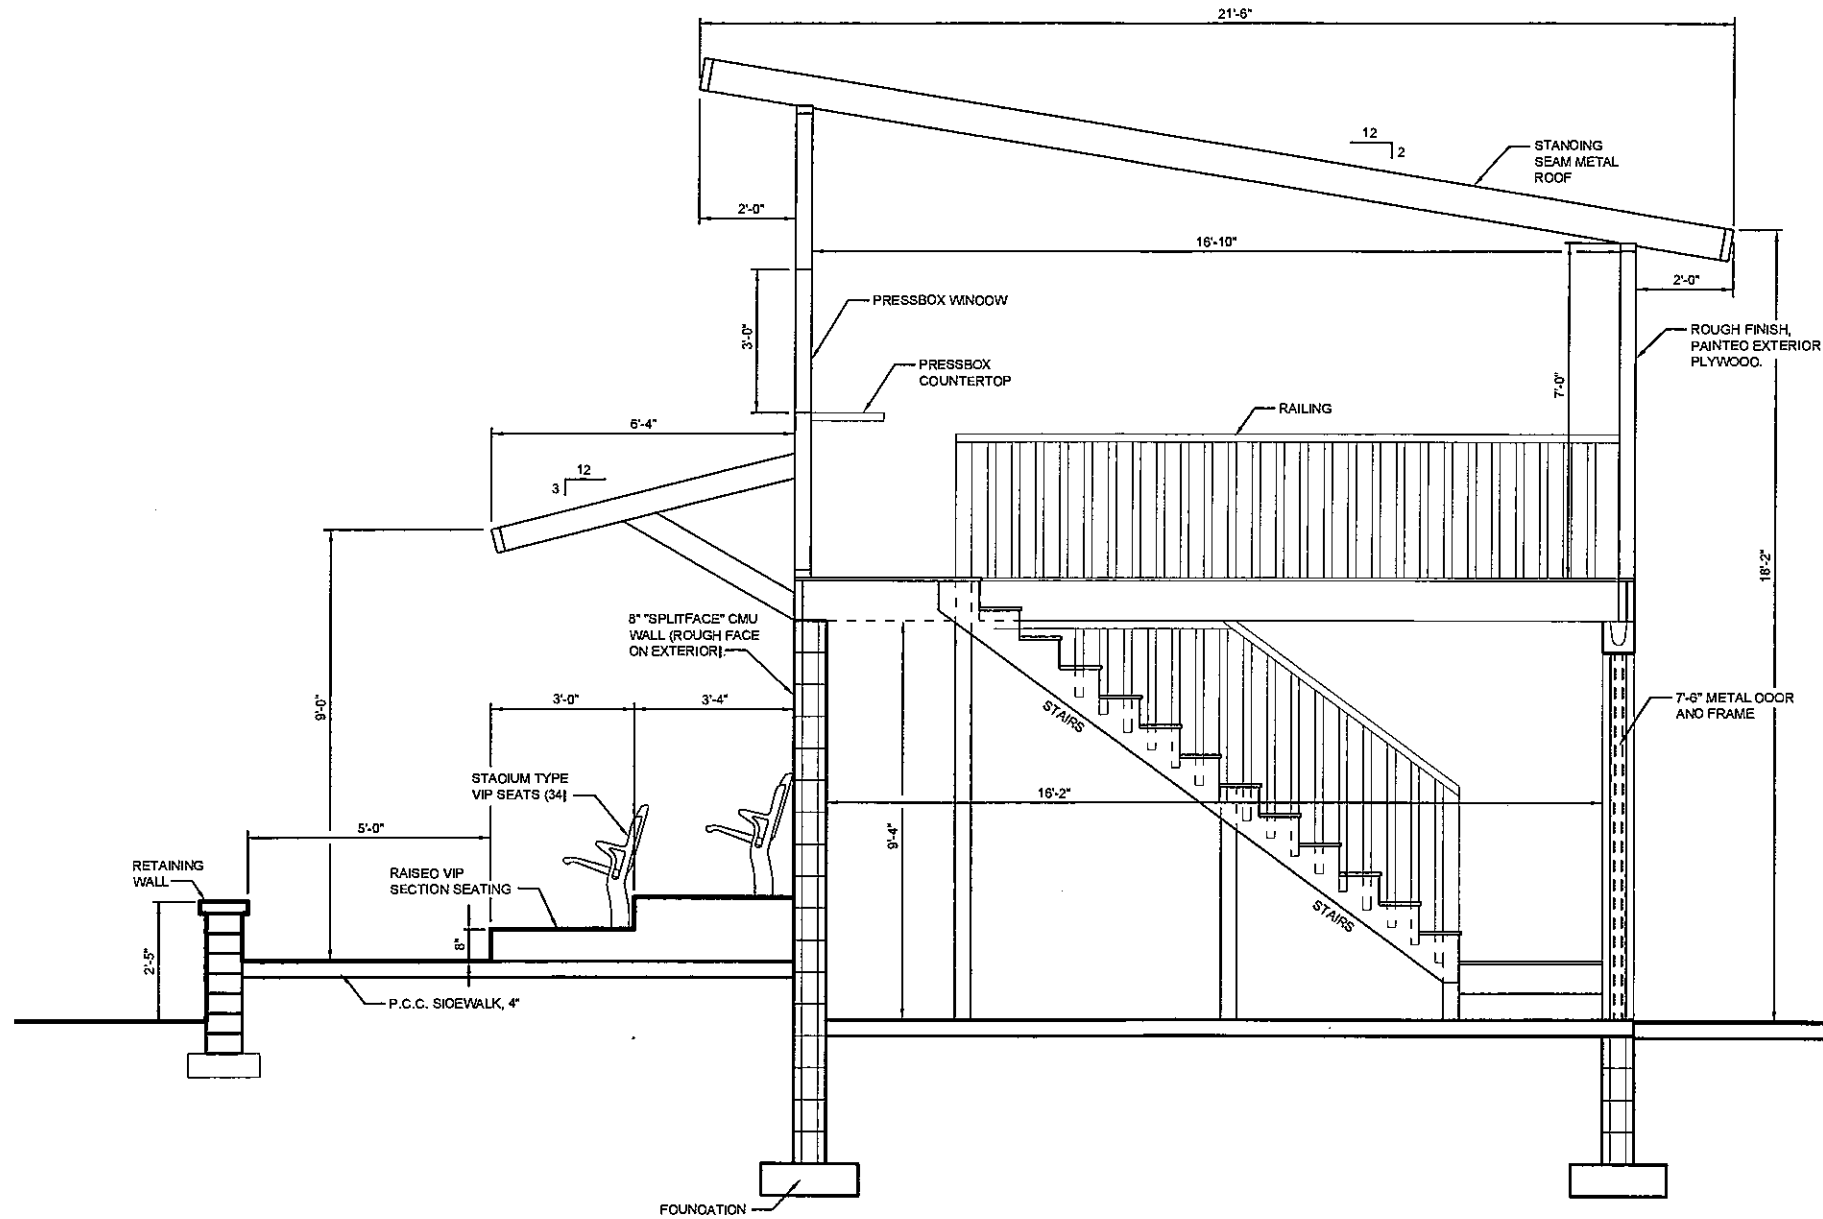

PRESSBOX SECTION 2-2

SCALE: 1/4" = 1'-0"

PRESSBOX SECTION

X:\PROJECTS\60099502\DWG\60099502_C5_SECTION.DWG

Drawn : NHP 08/20/09

Checked:


Approved:

PROJECT NUMBER 60099502

FIGURE NUMBER C5


PRESSBOX FIRST FLOOR

SCALE: 1/4"=1'-0"

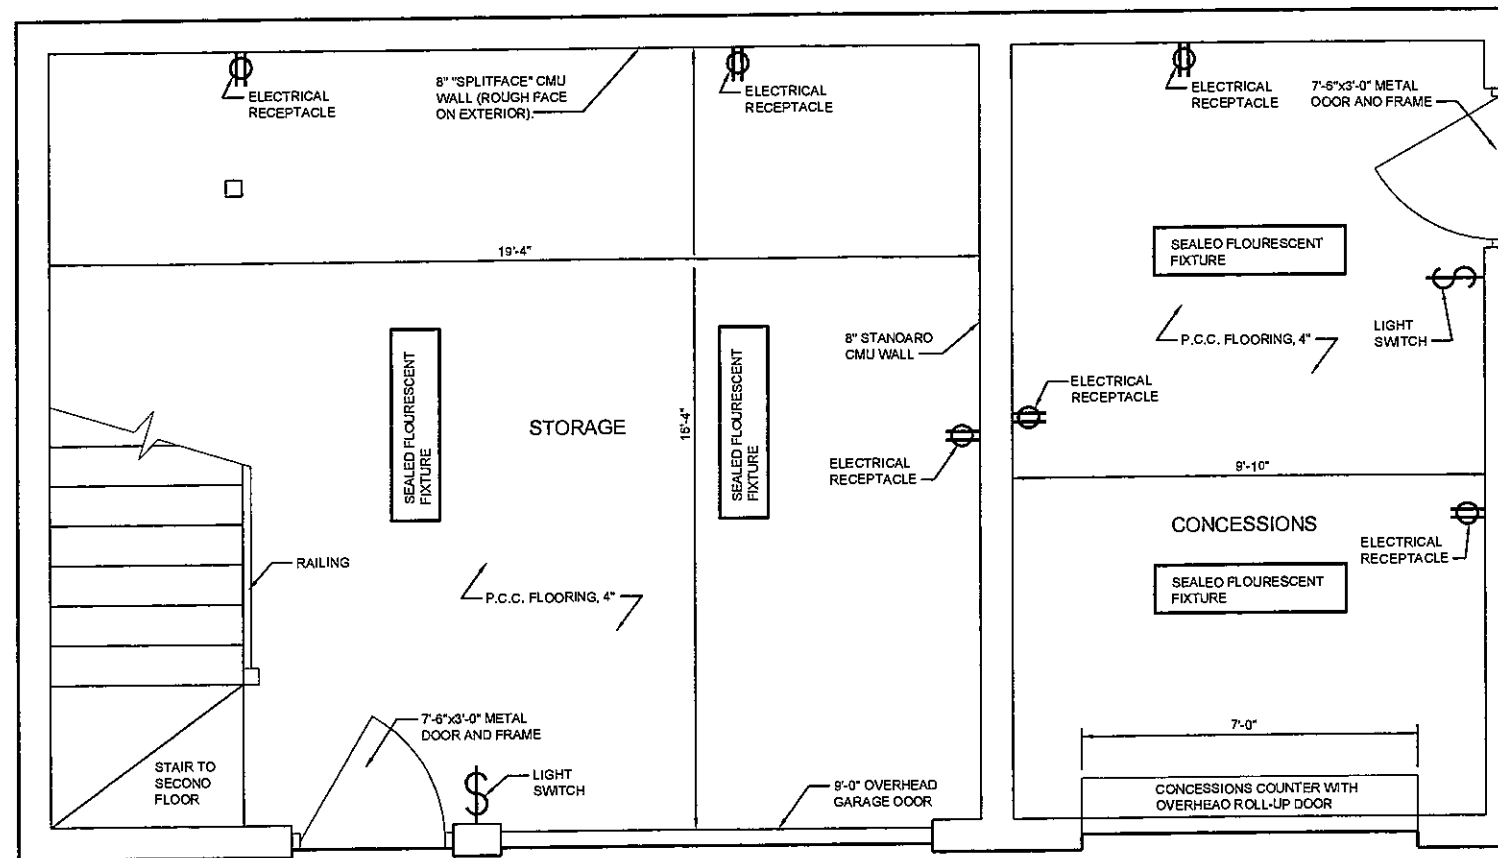

PRESSBOX SECOND FLOOR

SCALE: 1/4"=1'-0"

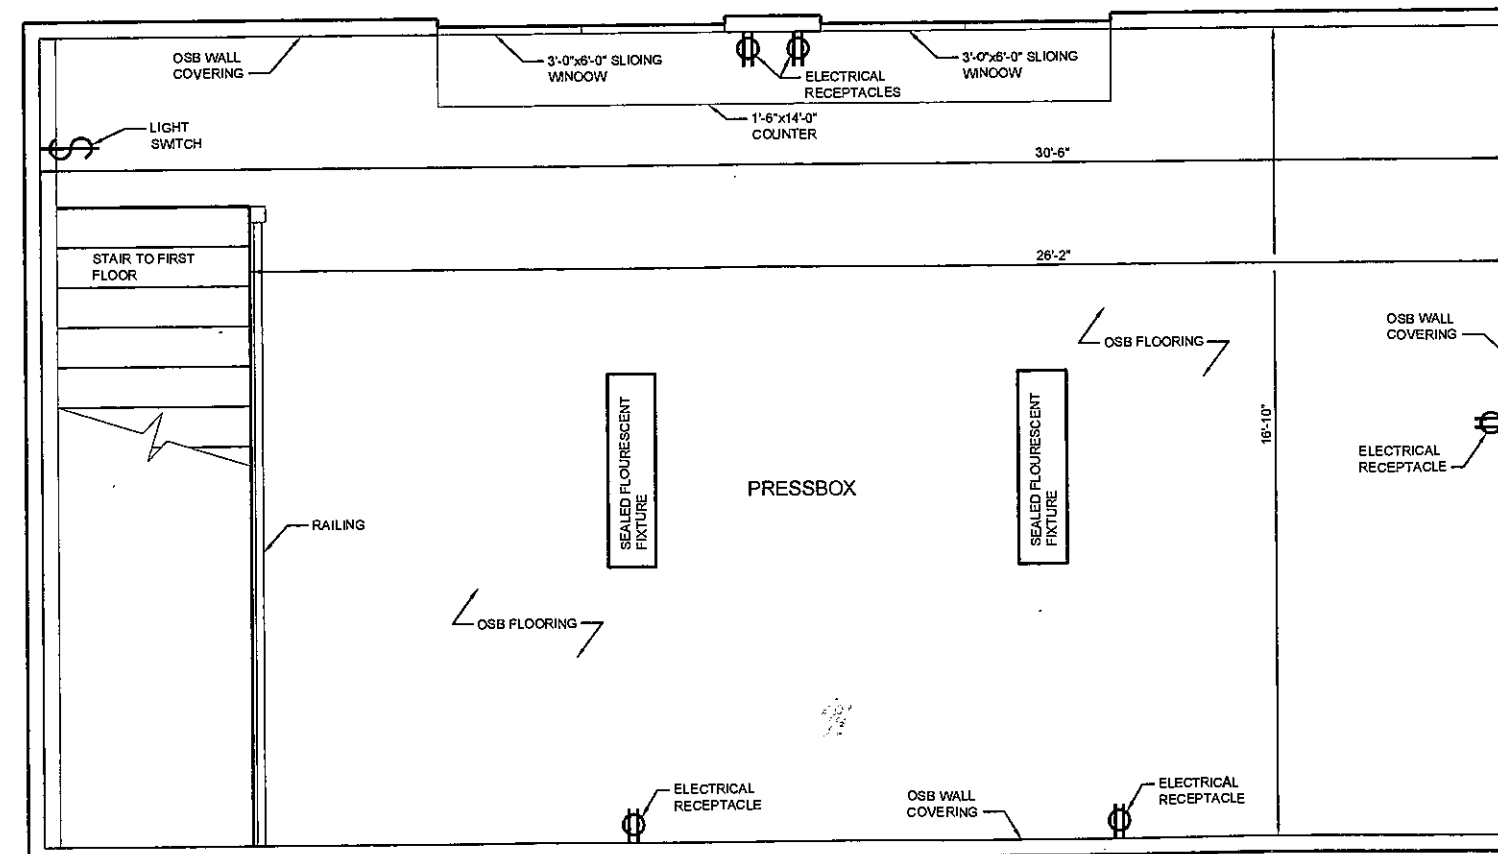

AECOM

111 N.E. Jefferson Ave.
Peoria, Illinois 61602
309-676-8464
www.aecom.com
Copyright © 2009 by AECOM
IL Design Firm Reg. Nos.
AECOM USA, Inc.
No. 184-003706
AECOM Technical Services
No. 184-000178

MORTON YOUTH
BASEBALL ASSOCIATION
MORTON, ILLINOIS

PRESSBOX FLOOR PLANS

X:\PROJECTS\60099502\DWG\60099502_A1_BLDGS.DWG

Drawn: NHP 08/20/09

Checked:


Approved:

PROJECT NUMBER 60099502

FIGURE NUMBER A1

MORTON YOUTH
 BASEBALL ASSOCIATION
 MORTON, ILLINOIS

DUGOUT FLOOR PLAN

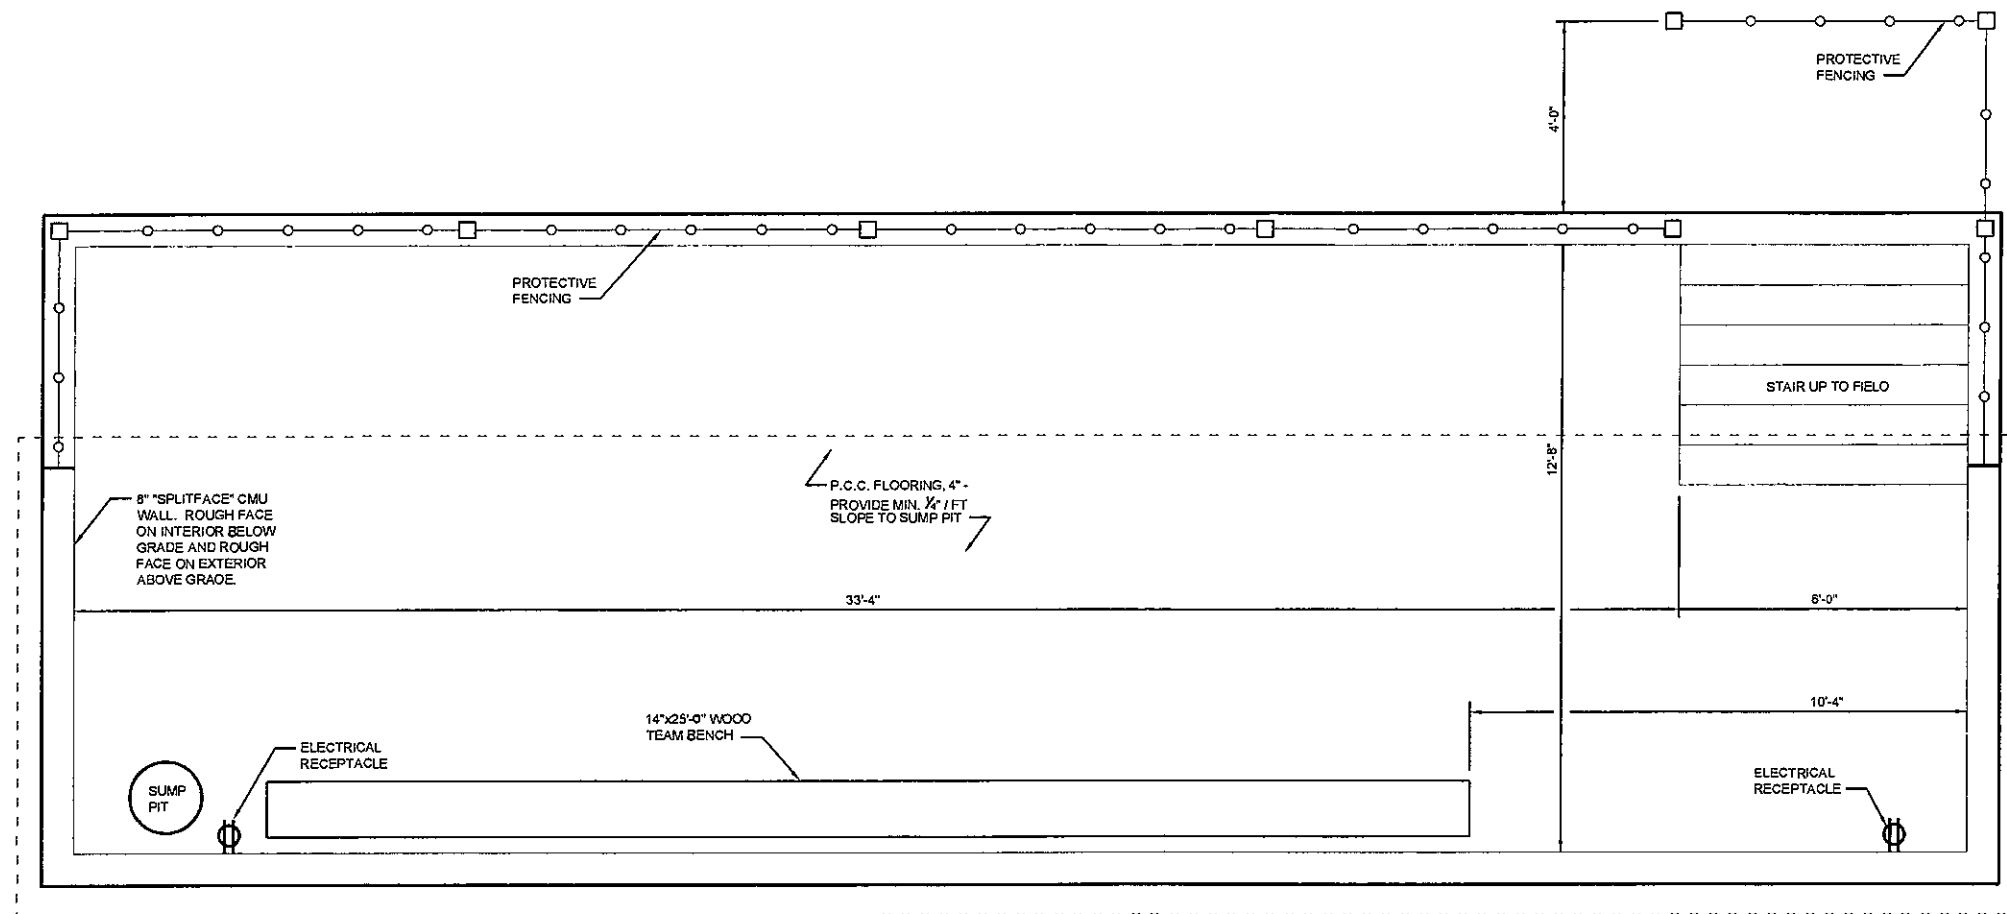

DUGOUT FLOOR PLAN

SCALE: 1/4" = 1'-0"

X:\PROJECTS\60099502\DWG\60099502_A2_BLDGS.DWG

Drawn : NHP 08/20/09

Checked:

Approved:

PROJECT NUMBER 60099502

FIGURE NUMBER A2

AECOM


111 N.E. Jefferson Ave.
Peoria, Illinois 61602
309-678-8464
www.aecom.com
Copyright © 2008 by AECOM
IL Design Firm Reg. Nos.
AECOM USA, Inc.
No. 184-0D3706
AECOM Technical Services
No. 184-000178

MORTON YOUTH
BASEBALL ASSOCIATION
MORTON, ILLINOIS

LIGHTPOLE LOCATIONS

X:\PROJECTS\60099502\DWG\60099502_E1_ELECTRICAL.DWG

Drawn :	NHP 08/20/09
Checked:	
Approved:	
PROJECT NUMBER	60099502
FIGURE NUMBER	E1

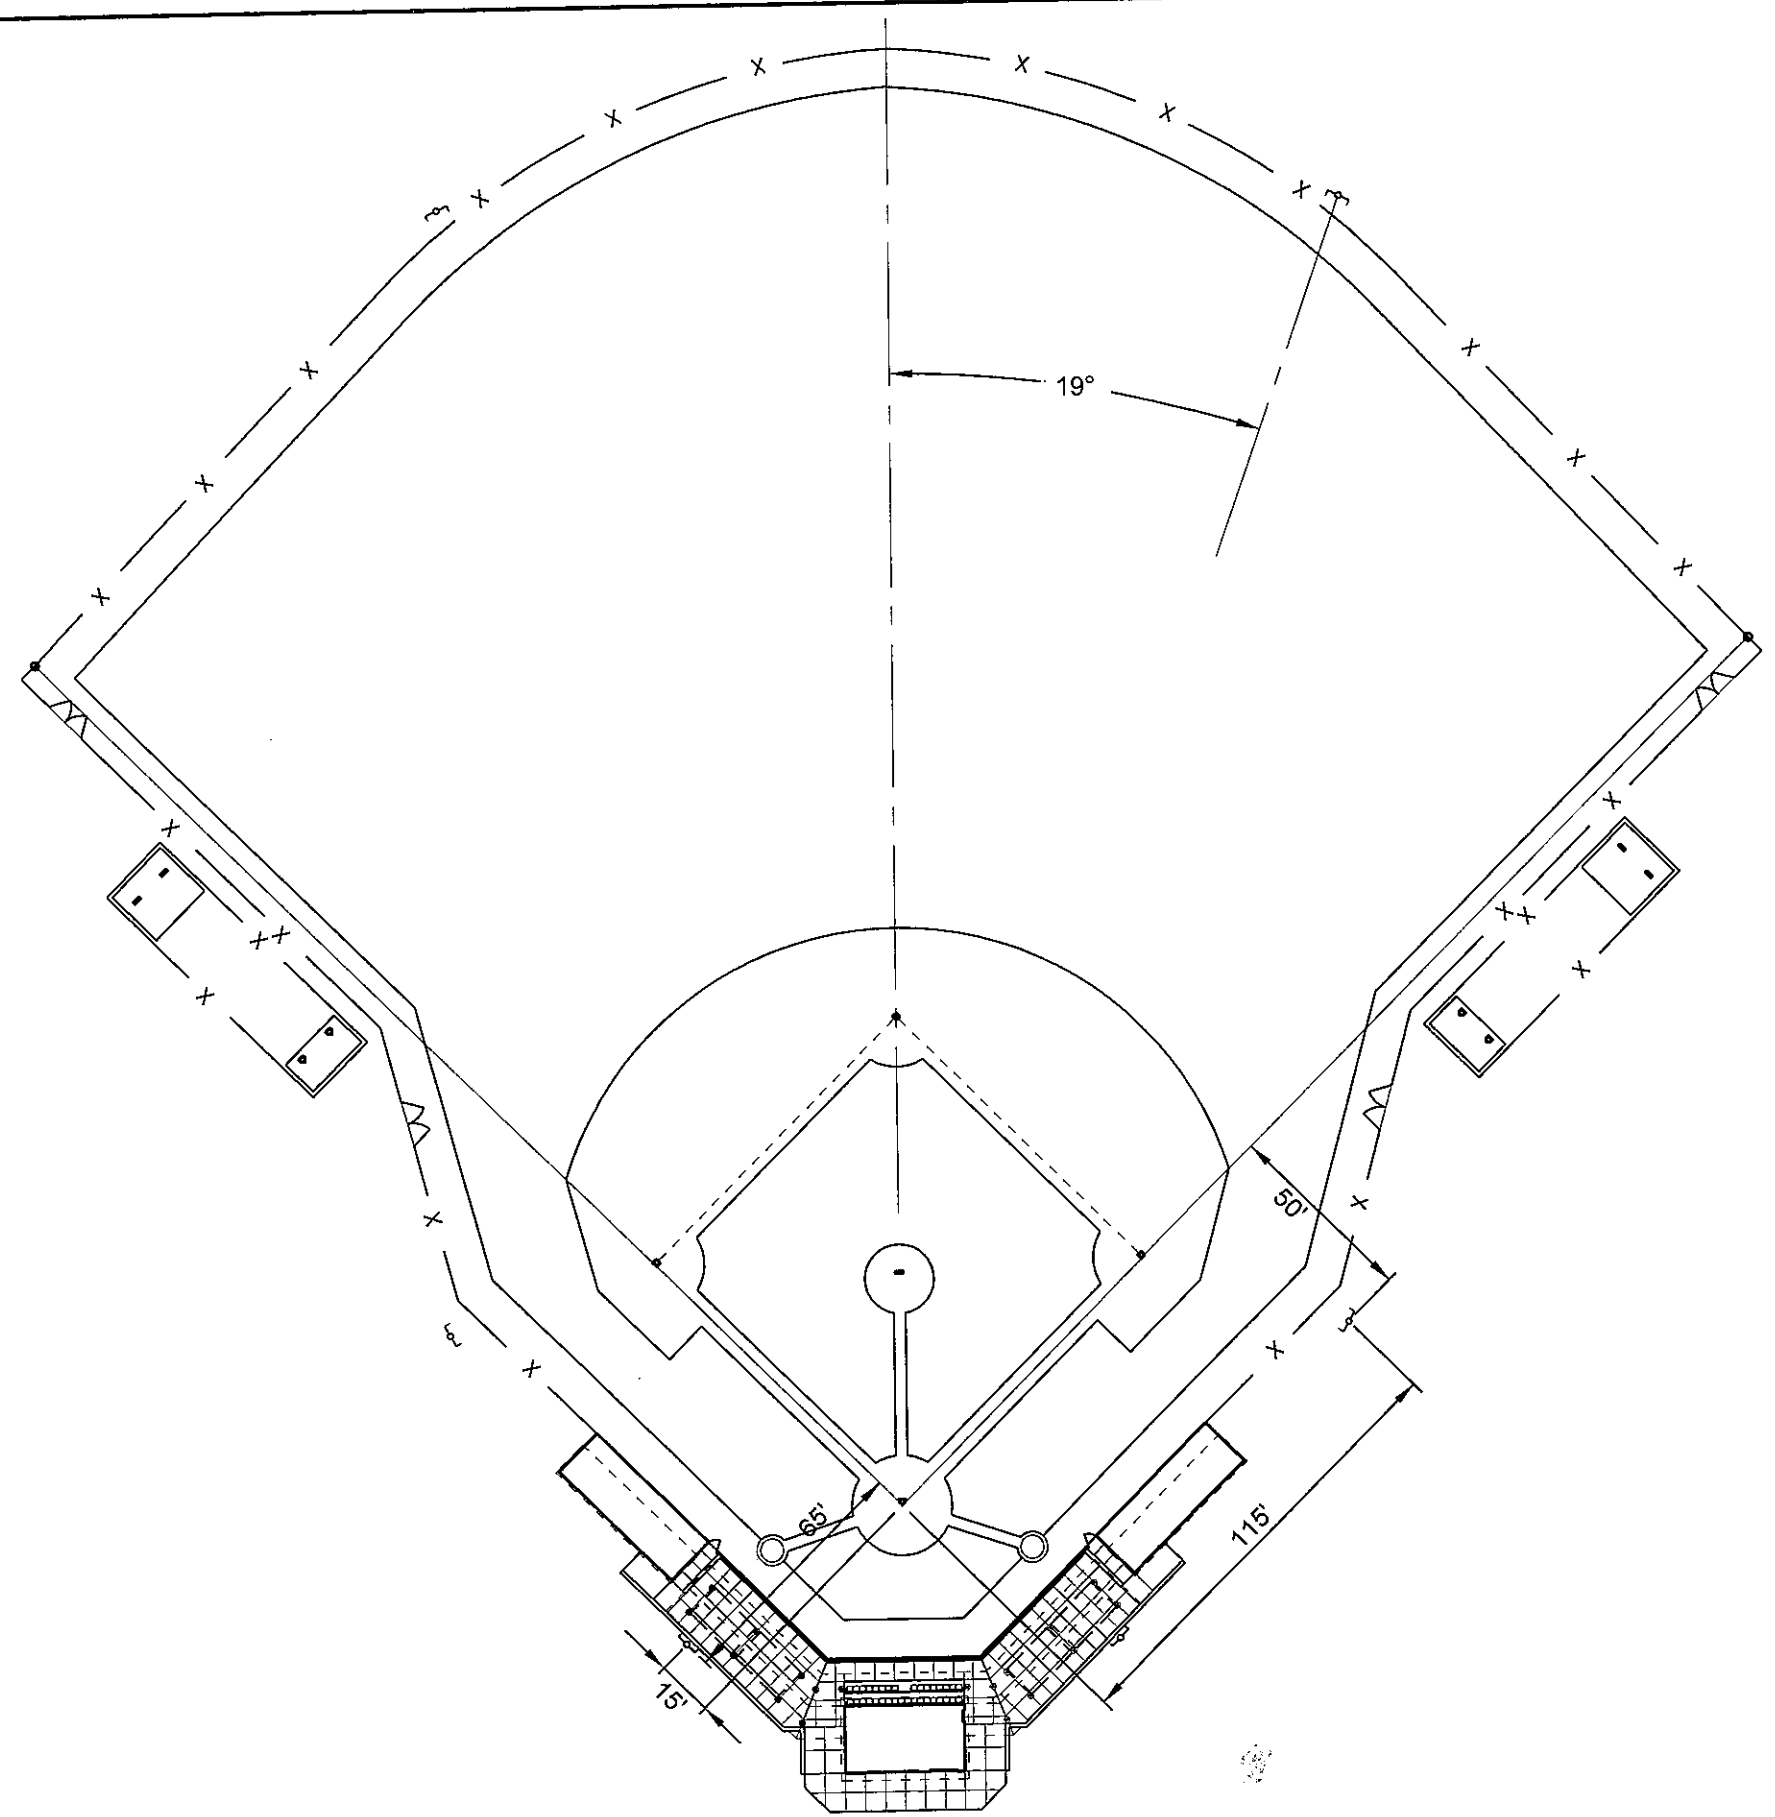

LIGHTPOLE LOCATIONS

SCALE: 1"=80'-0"

